


RIVER CAMPUS SUMMER 2024 PROJECT WORK

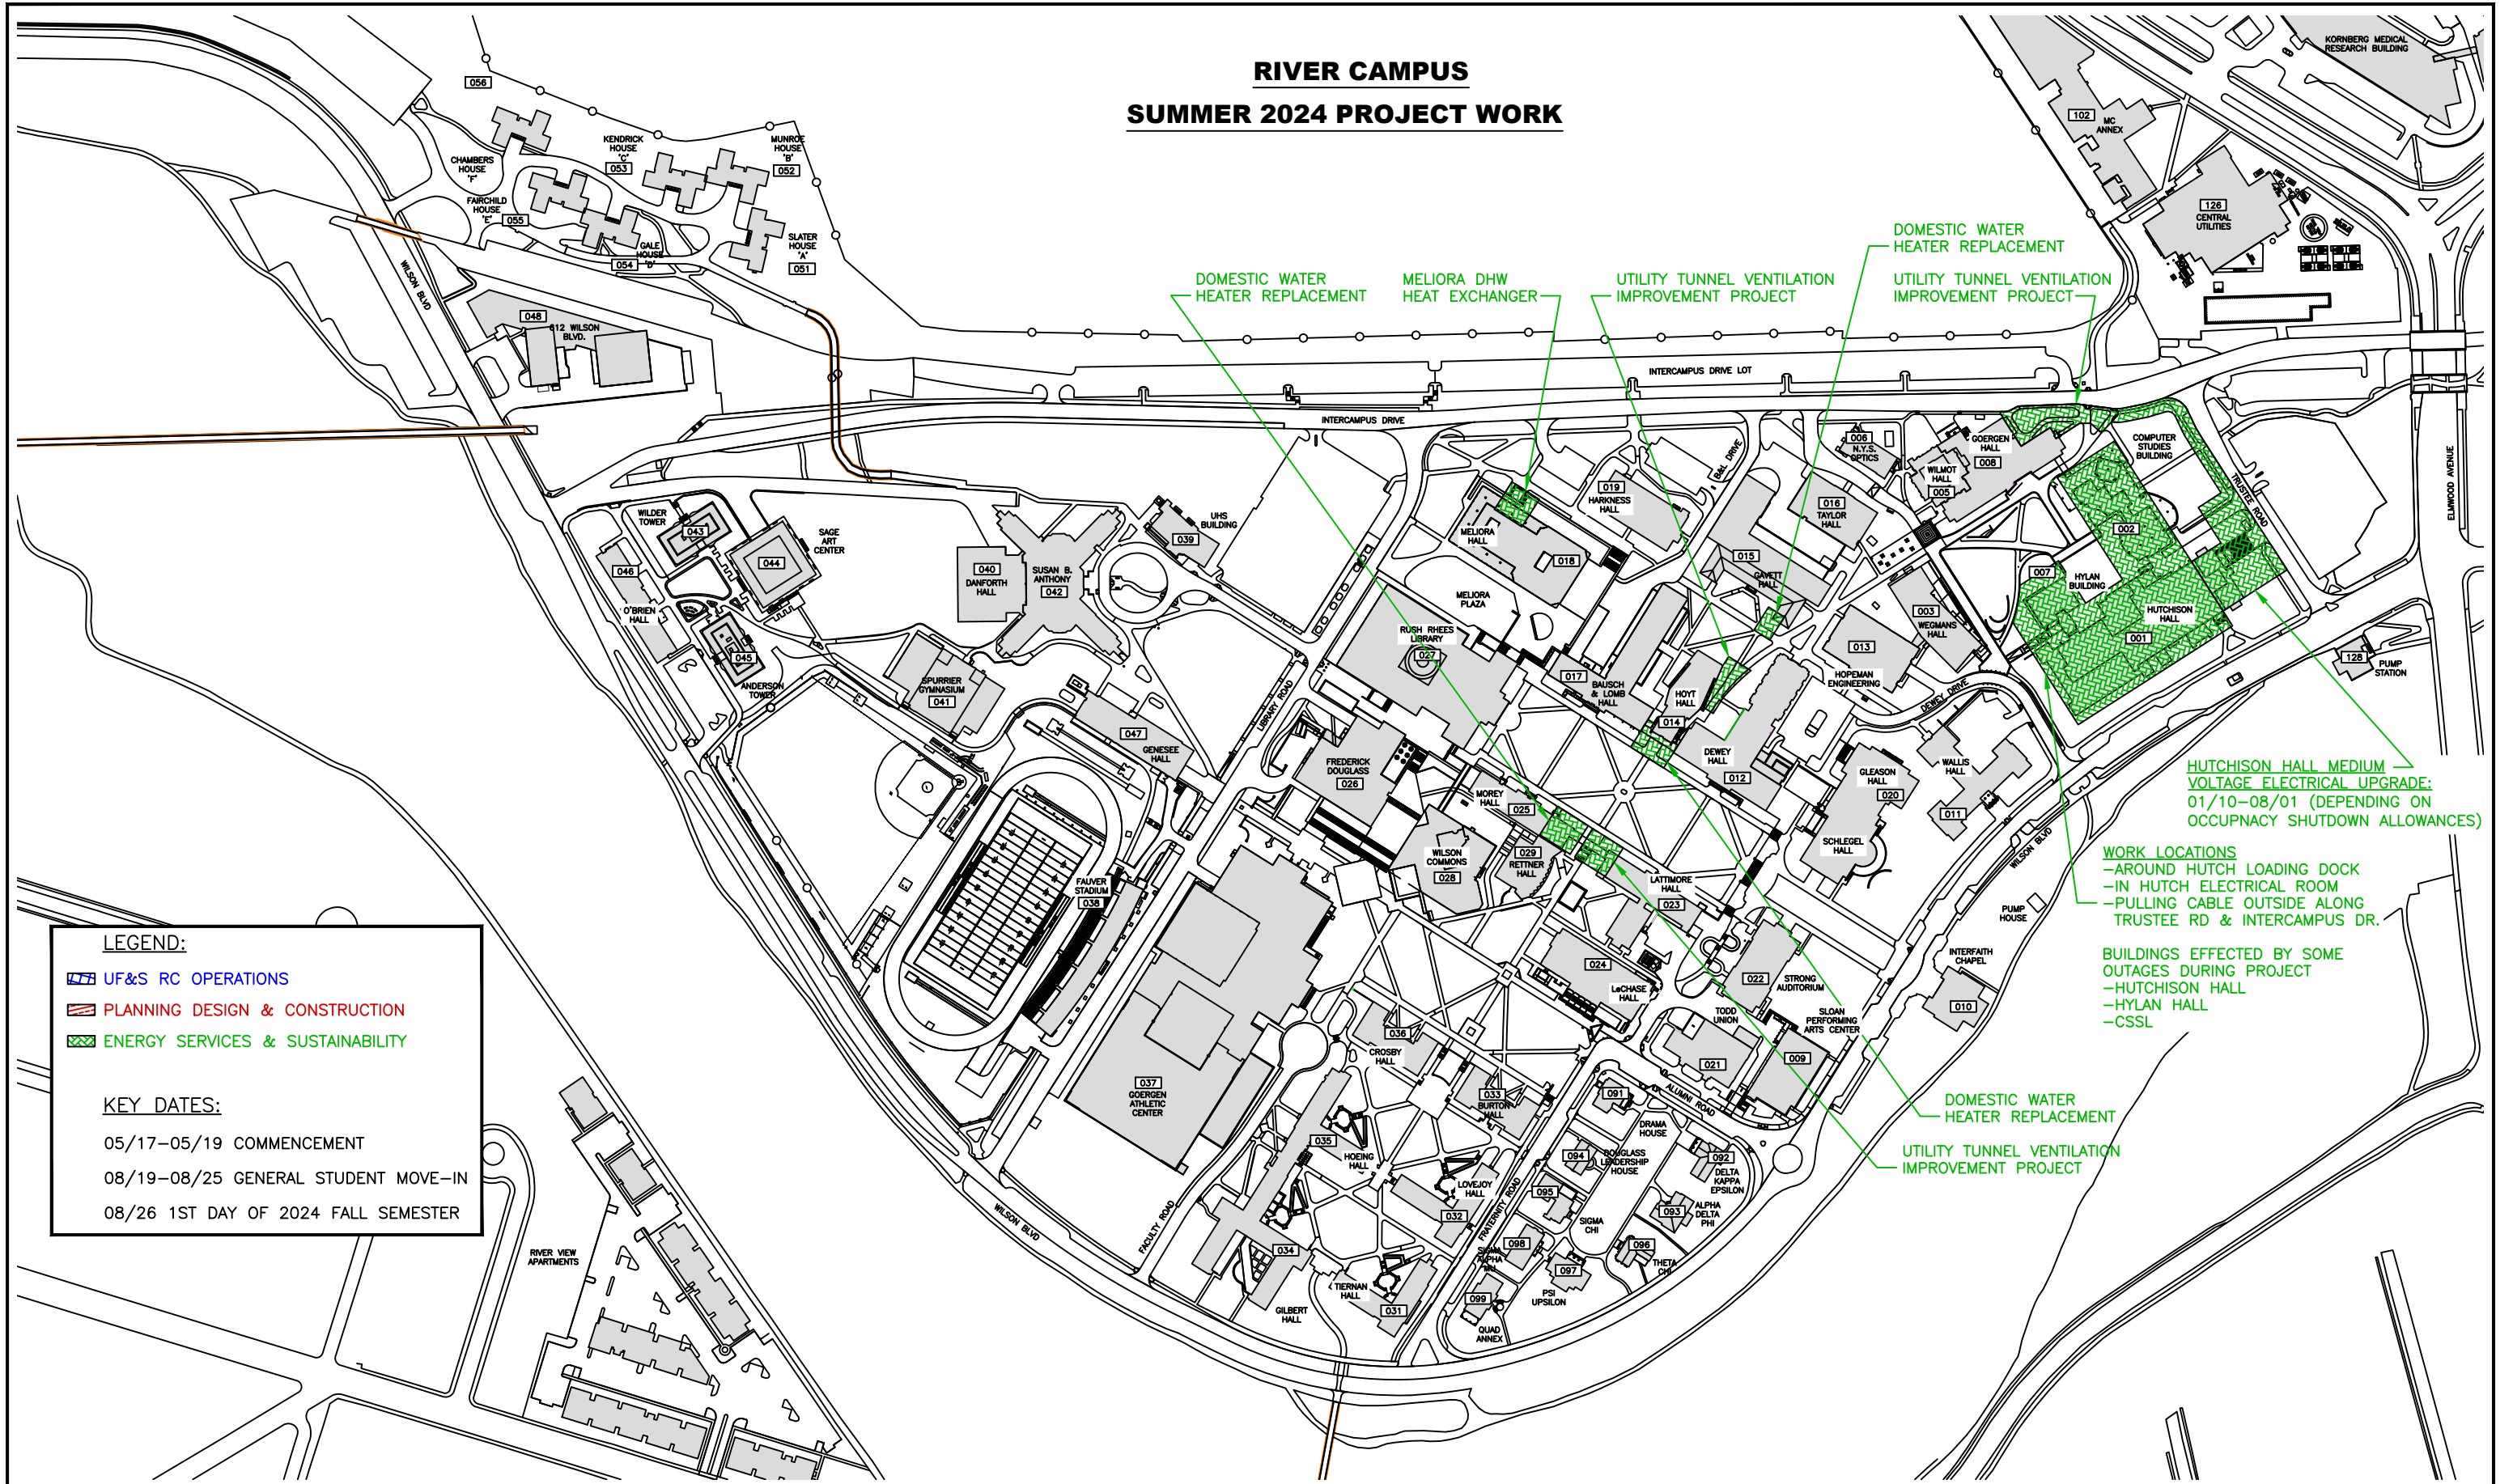

LEGEND:

- UF&S RC OPERATIONS
- PLANNING DESIGN & CONSTRUCTION
- ENERGY SERVICES & SUSTAINABILITY

KEY DATES:

05/17-05/19 COMMENCEMENT

08/19-08/25 GENERAL STUDENT MOVE-IN

08/26 1ST DAY OF 2024 FALL SEMESTER

DOMESTIC WATER HEATER REPLACEMENT MELIORA DHW HEAT EXCHANGER UTILITY TUNNEL VENTILATION IMPROVEMENT PROJECT UTILITY TUNNEL VENTILATION IMPROVEMENT PROJECT

HUTCHISON HALL MEDIUM VOLTAGE ELECTRICAL UPGRADE: 01/10-08/01 (DEPENDING ON OCCUPANCY SHUTDOWN ALLOWANCES)

WORK LOCATIONS
 -AROUND HUTCH LOADING DOCK
 -IN HUTCH ELECTRICAL ROOM
 -PULLING CABLE OUTSIDE ALONG TRUSTEE RD & INTERCAMPUS DR.

BUILDINGS EFFECTED BY SOME OUTAGES DURING PROJECT
 -HUTCHISON HALL
 -HYLAN HALL
 -CSSL

DOMESTIC WATER HEATER REPLACEMENT UTILITY TUNNEL VENTILATION IMPROVEMENT PROJECT

UNIVERSITY of ROCHESTER	DRAWN OR REVISED BY: KEVIN KEHOE	DRAWING NAME: RIVER CAMPUS SITE 2024 PROJECTS	BUILDING NAME: AS NOTED	DRAWING LOCATION: H:\WORKING PLANS\SITE\AUTOCAD BASE SITE DRAWINGS\ RIVER CAMPUS SITE PLANS\RC 2024 SUMMER PROJECTS
	DATE DRAWN OR REVISED: 03-06-24	DRAWING SCALE: NOT TO SCALE	BUILDING NUMBER: AS NOTED	PLANNING AND PROJECT MANAGEMENT